

BID DOCUMENTS
FREEMAN LAKE PARK OFFICE
 ELIZABETHTOWN, KY 42701




PLUMBING	
PROJECT	2016-1340
DATE	8/18/2017
DRAWN	VW
CHECKED	VW

No.	Description	Date
		8-22-17
1	CHANGED SEWER EXIT	


ICON ENGINEERING AND INSPECTION SERVICES, PLLC HAS RETAINED AN ELECTRONIC VERSION OF THESE DRAWINGS. THE CLIENT AGREES NOT TO REPRODUCE, REUSE, OR COPY THESE DRAWINGS IN ELECTRONIC OR ANY OTHER FORMAT IN WHOLE OR IN PART FOR ANY PURPOSE OTHER THAN THE SPECIFIC PROJECT LOCATION NOTED IN THE PROJECT TITLE BLOCK. THE CLIENT AGREES NOT TO TRANSFER THESE ELECTRONIC FILES TO OTHERS WITHOUT THE PRIOR WRITTEN CONSENT OF ICON ENGINEERING AND INSPECTION SERVICES, PLLC. THE CLIENT FURTHER AGREES TO WAIVE ALL CLAIMS AGAINST ICON ENGINEERING AND INSPECTION SERVICES, PLLC RESULTING IN ANY WAY FROM ANY UNAUTHORIZED CHANGES TO OR REUSE OF THE ELECTRONIC FILES FOR ANY OTHER PROJECT BY ANYONE OTHER THAN ICON ENGINEERING AND INSPECTION SERVICES, PLLC.

PLUMBING PLAN

P-100

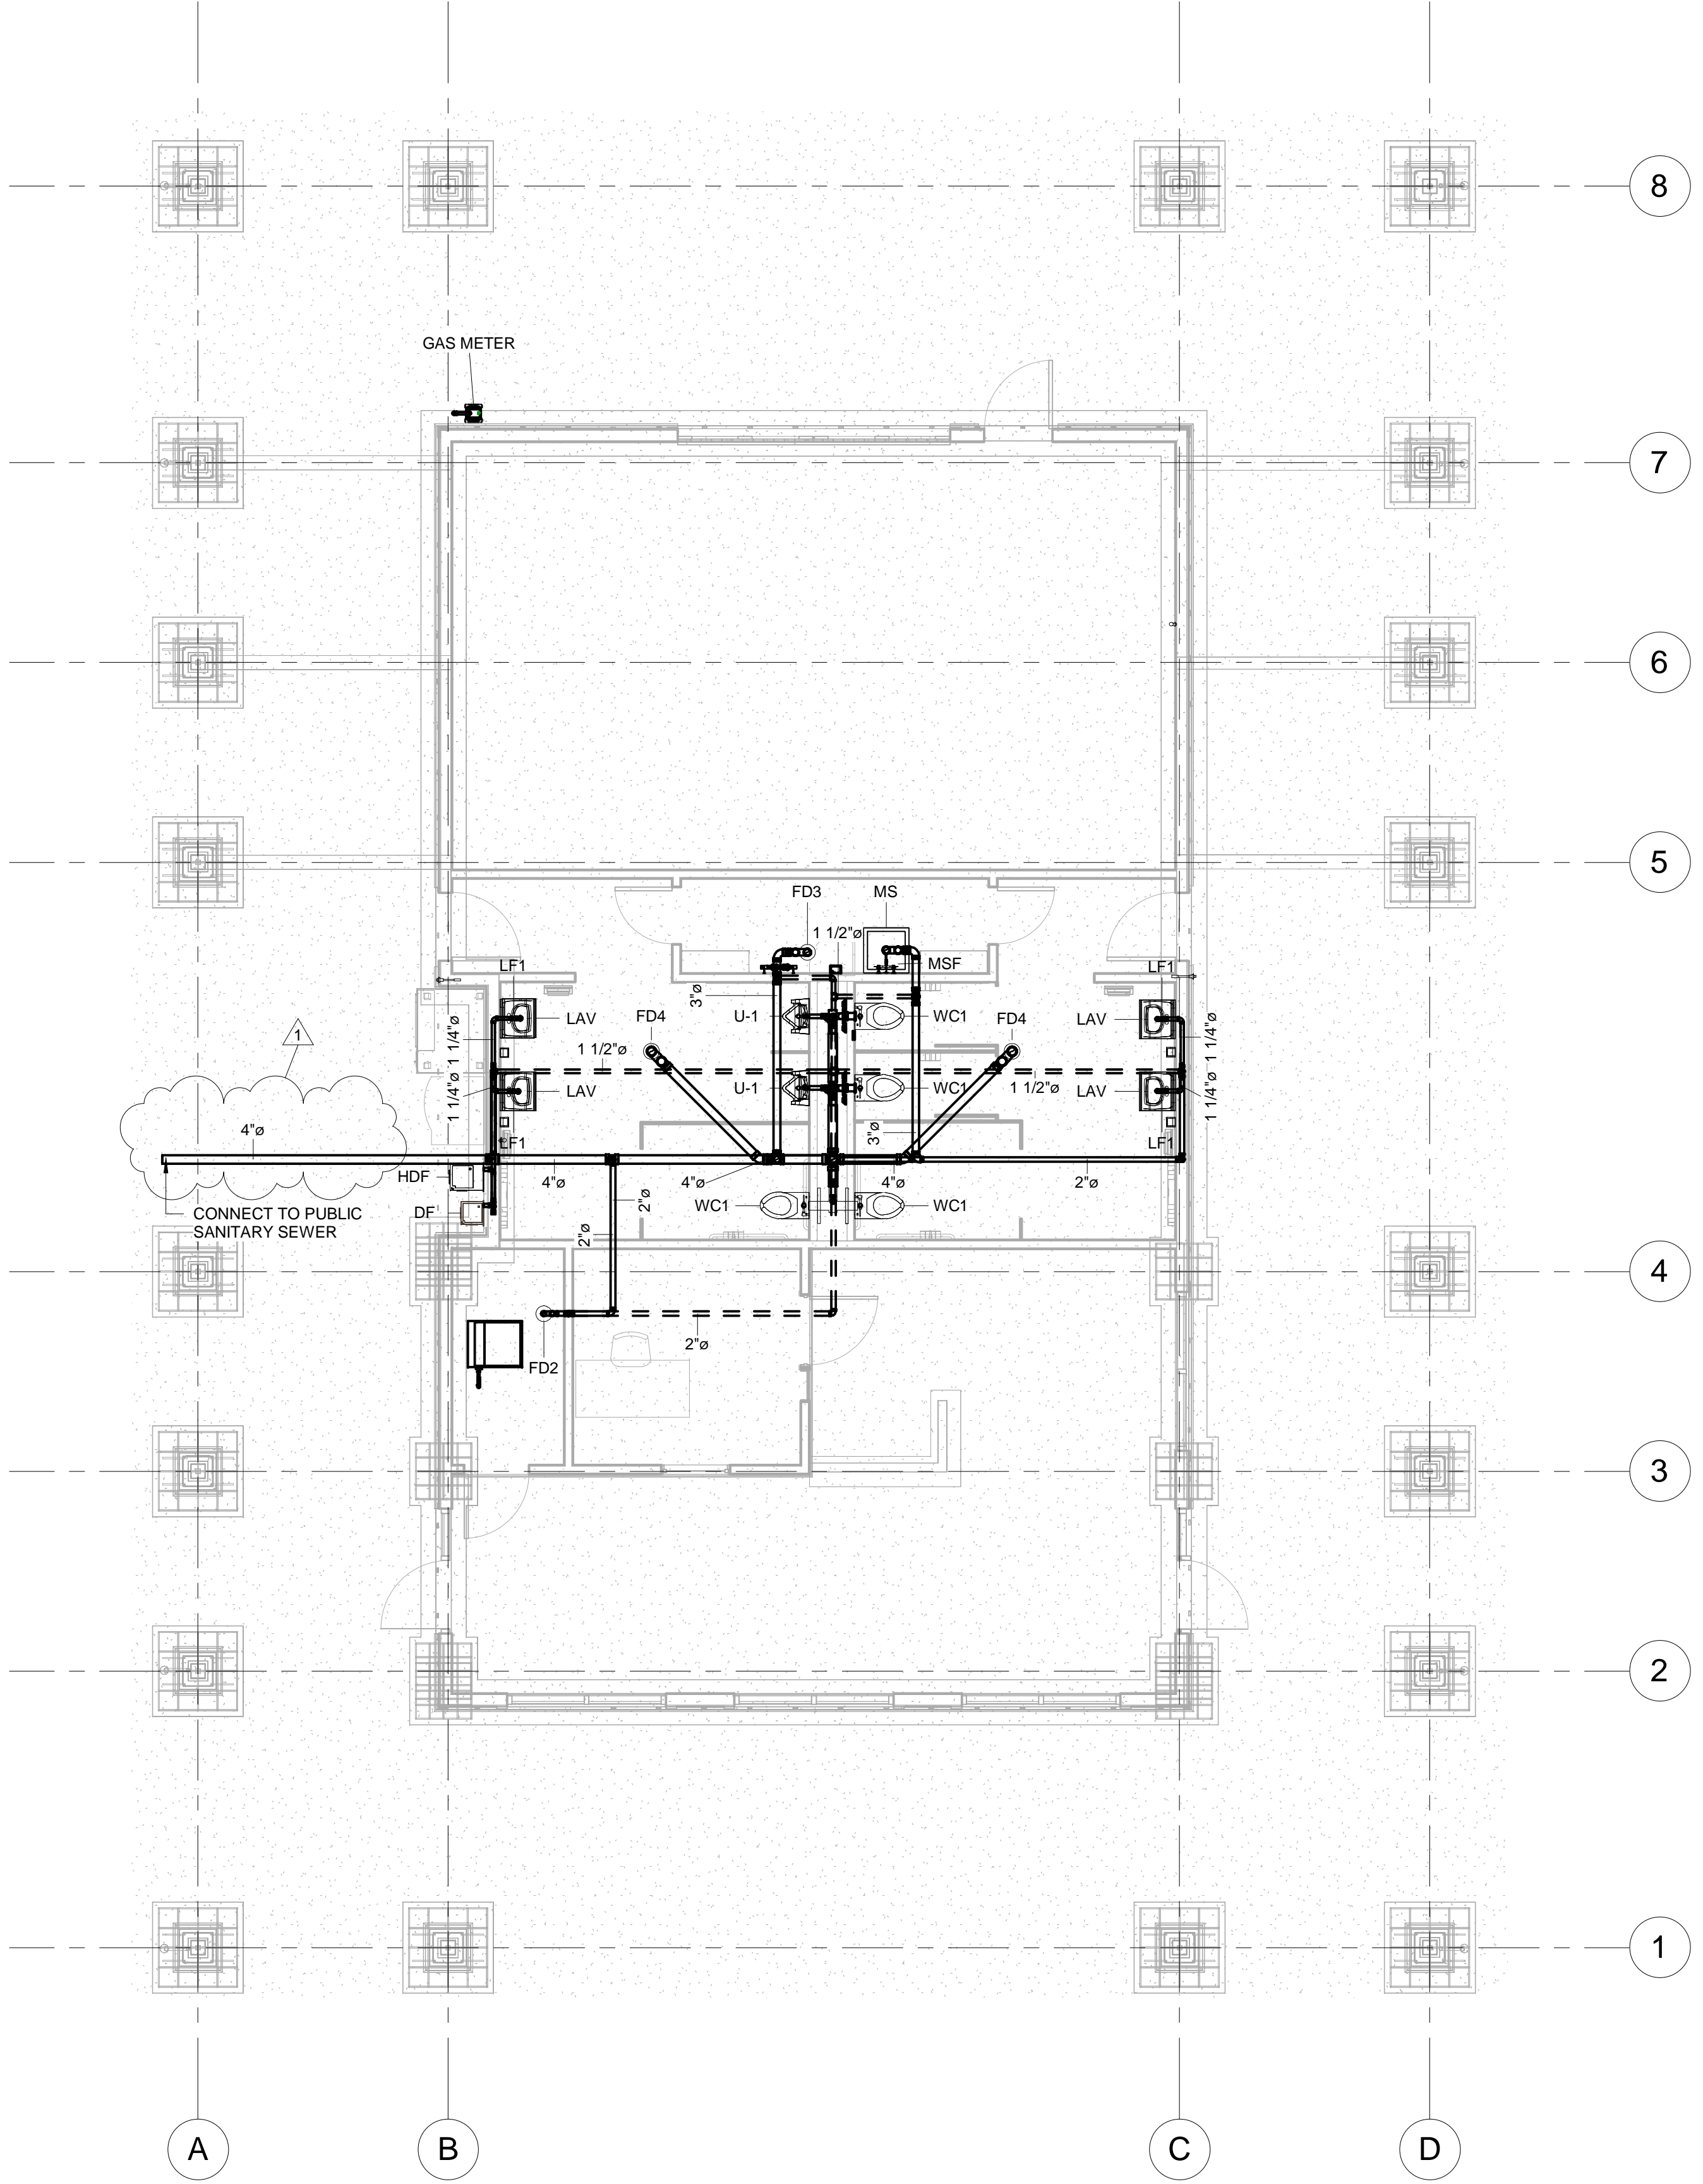

1 1 - SANITARY PIPING
 SCALE: 3/16" = 1'-0"

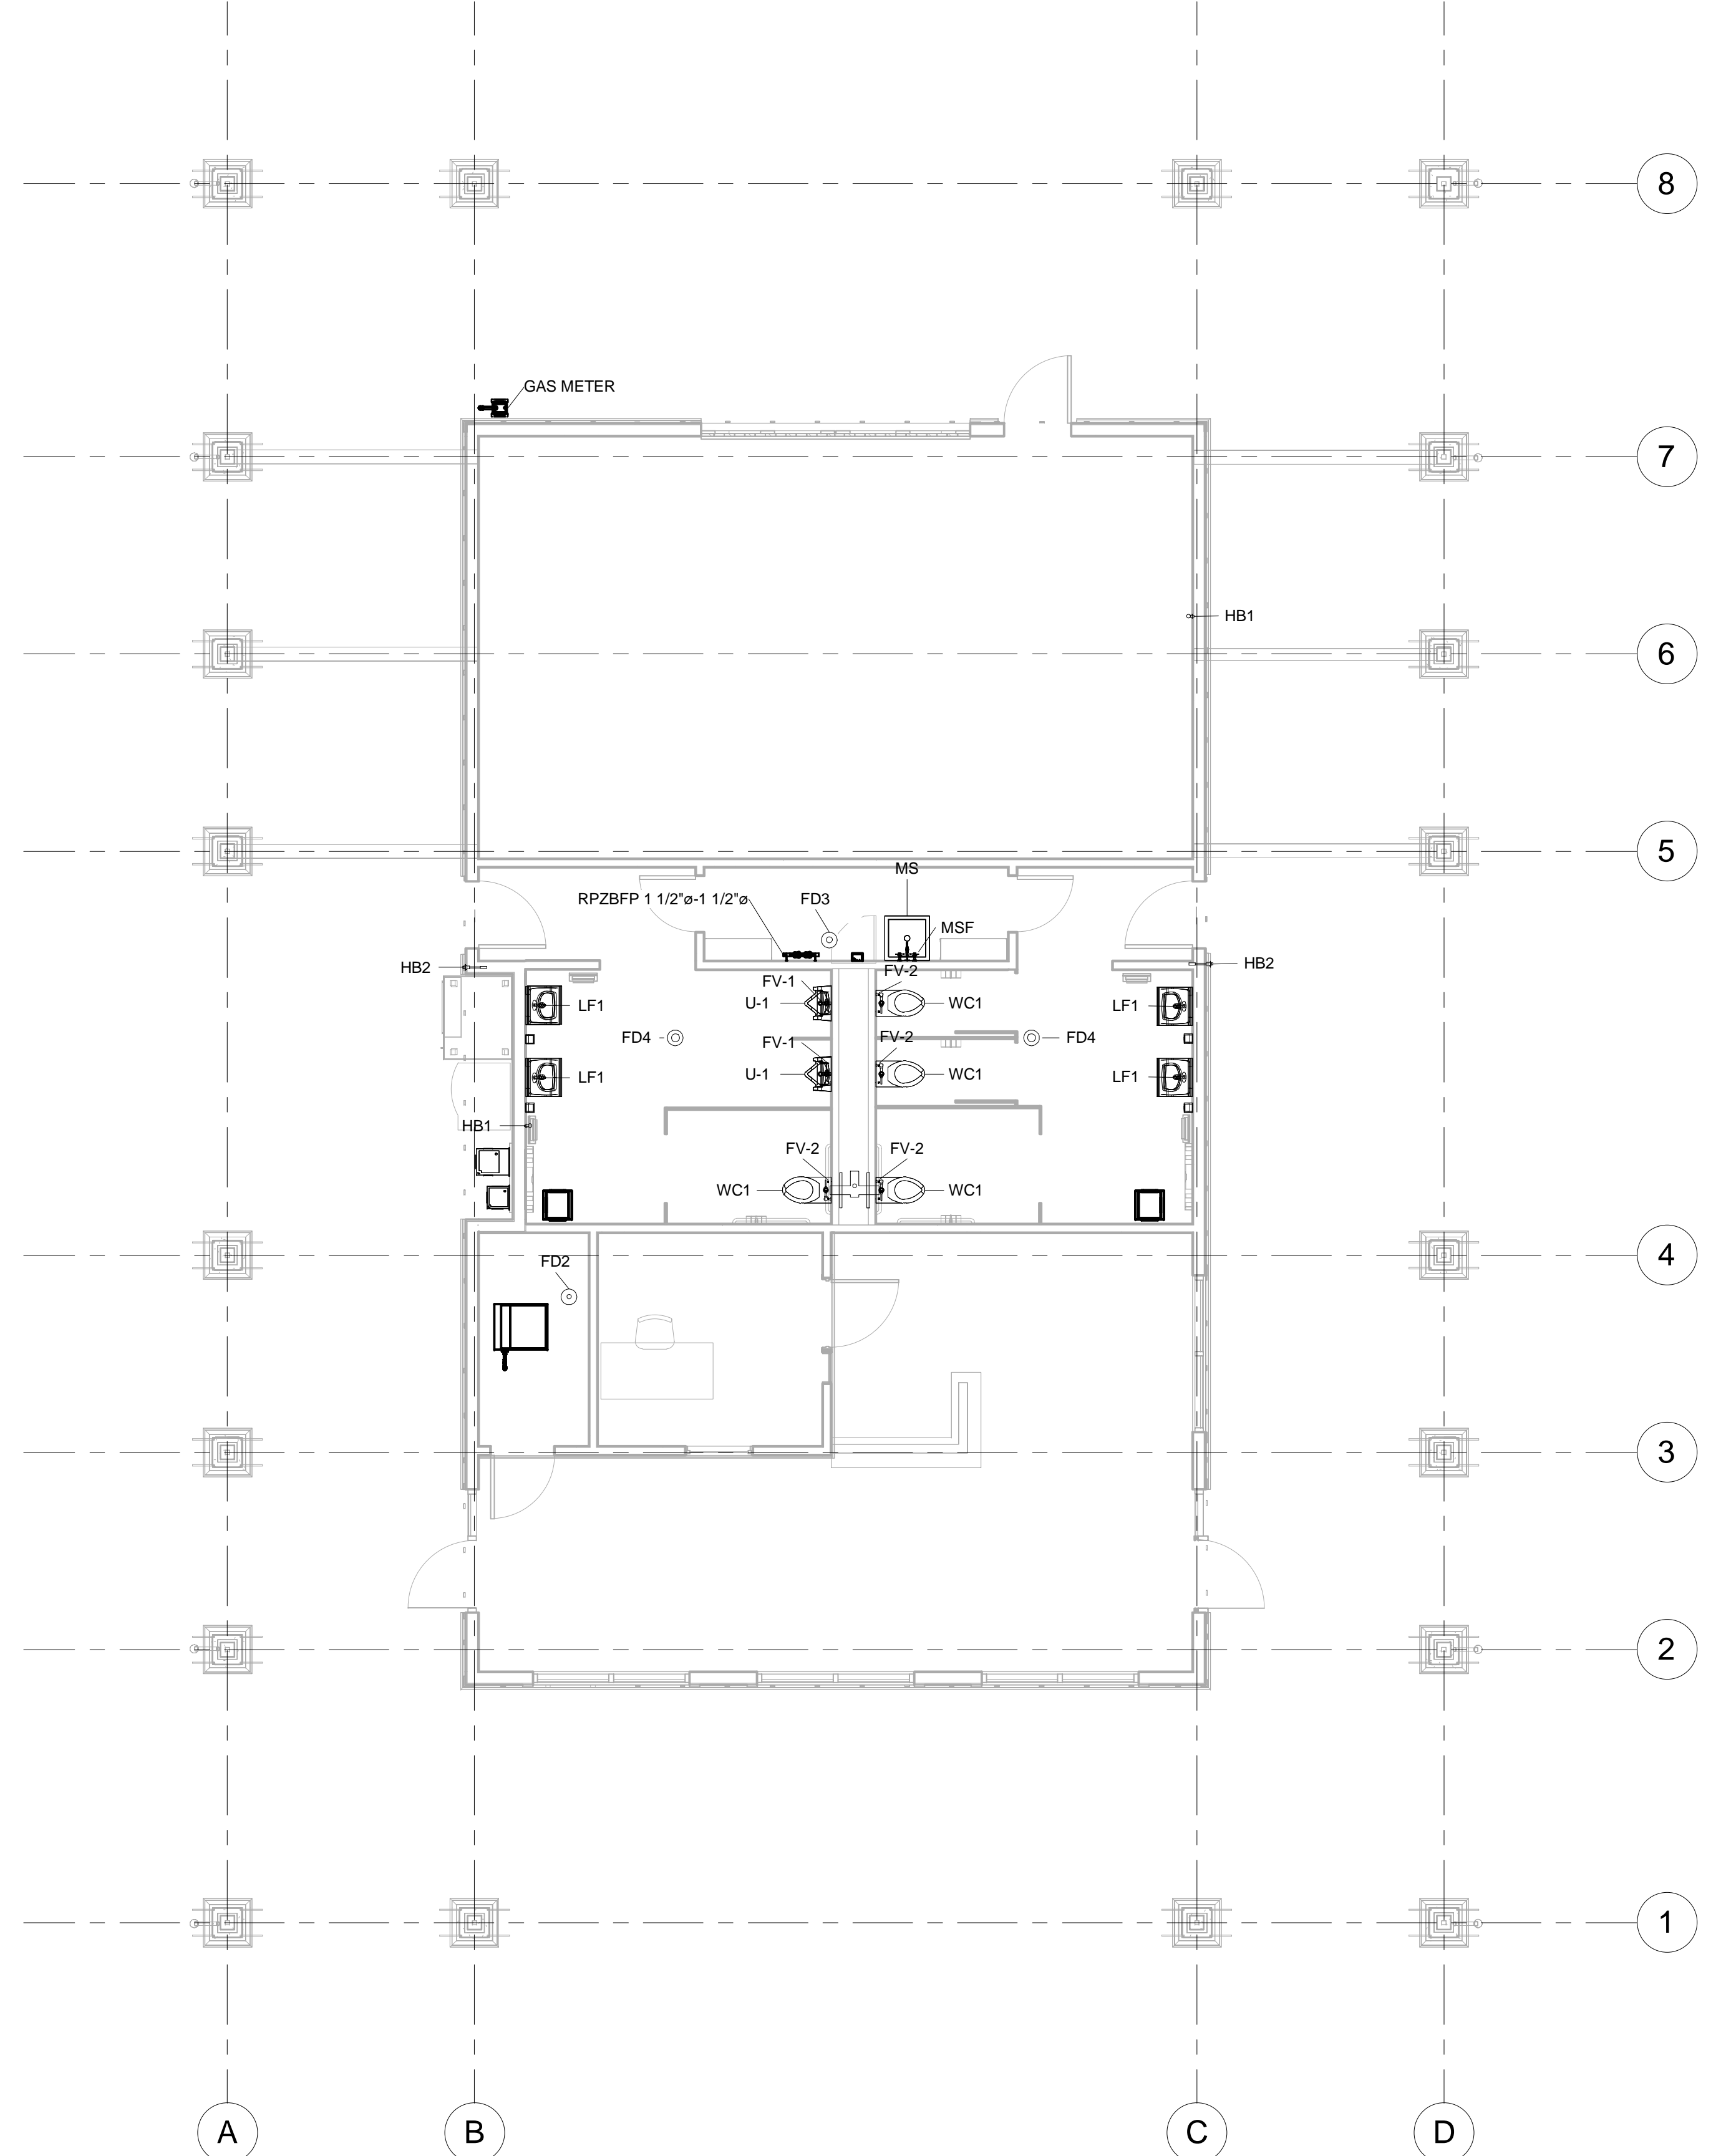

2 1 - DOMESTIC WATER PIPING
 SCALE: 3/16" = 1'-0"